



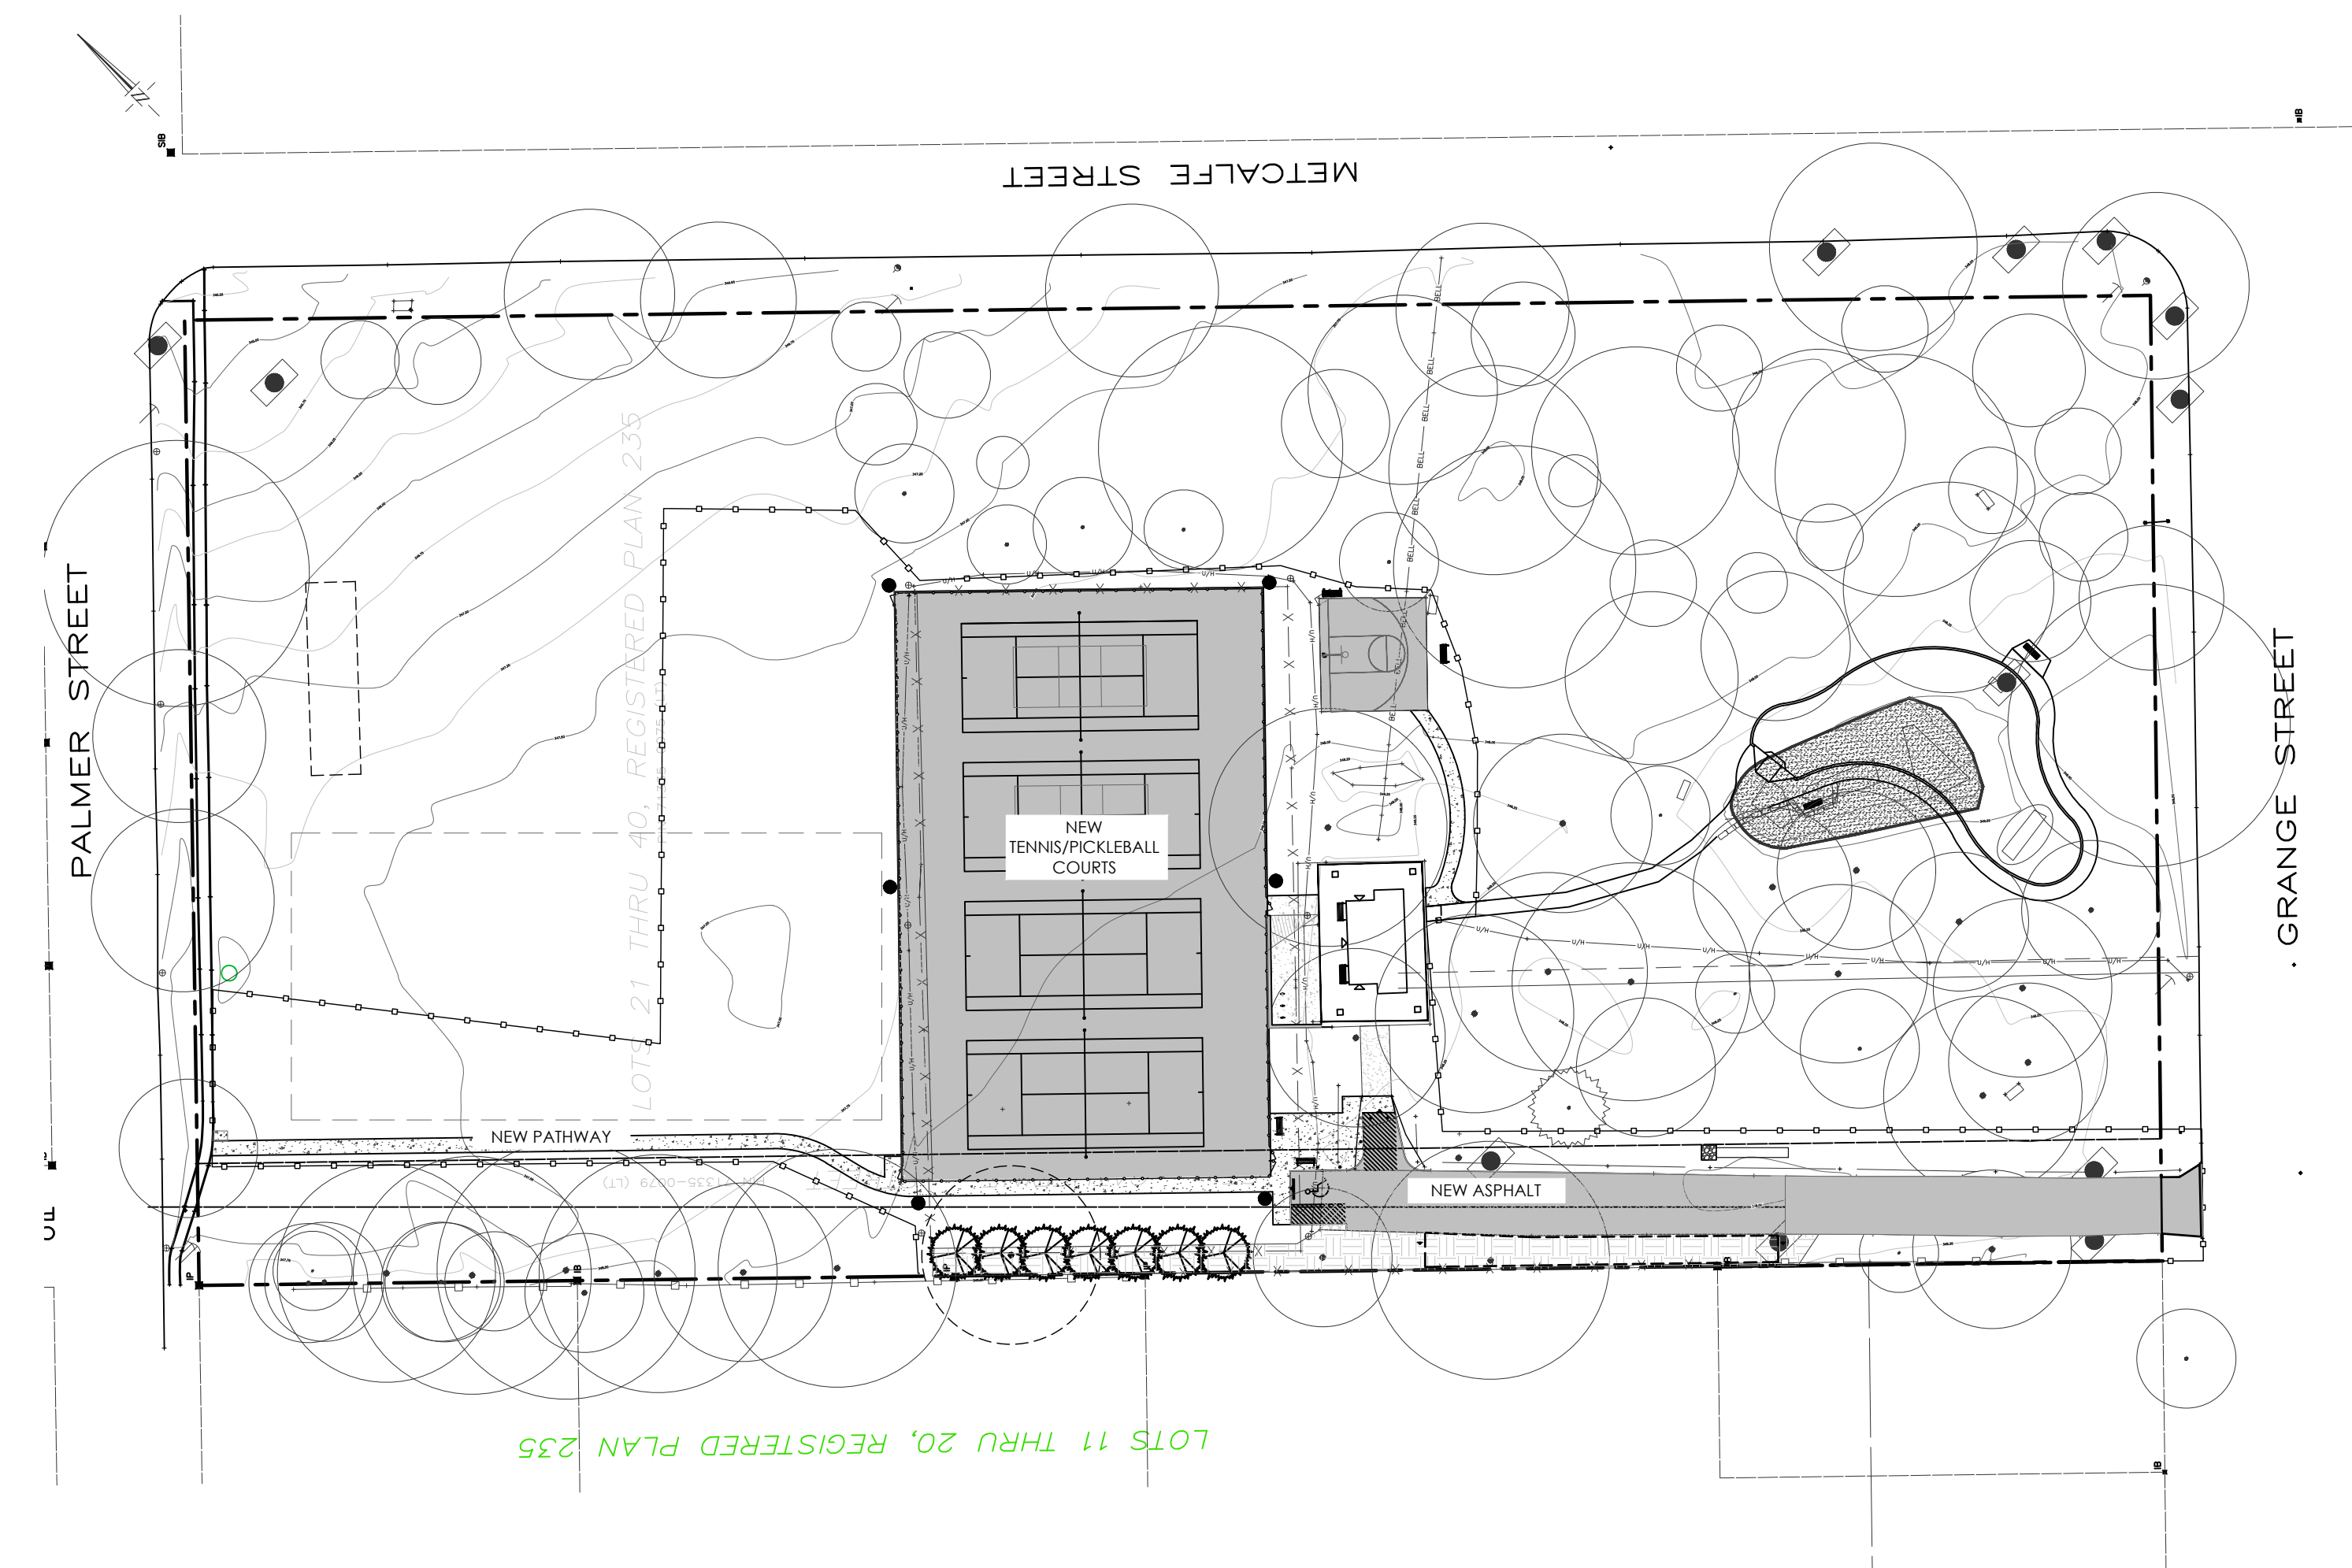

DRAWINGS

- L1 TITLE PAGE
- L2 TREE MANAGEMENT PLAN
- L3 CONSTRUCTION MANAGEMENT AND REMOVALS PLAN
- L4 LAYOUT/PLANTING PLAN
- L5 GRADING PLAN
- L6 DETAILS
- L7 DETAILS
- E1 SITE LIGHTING PLAN
- E2 SCHEDULES AND SPECIFICATIONS

PRELIMINARY
For Discussion Purposes only

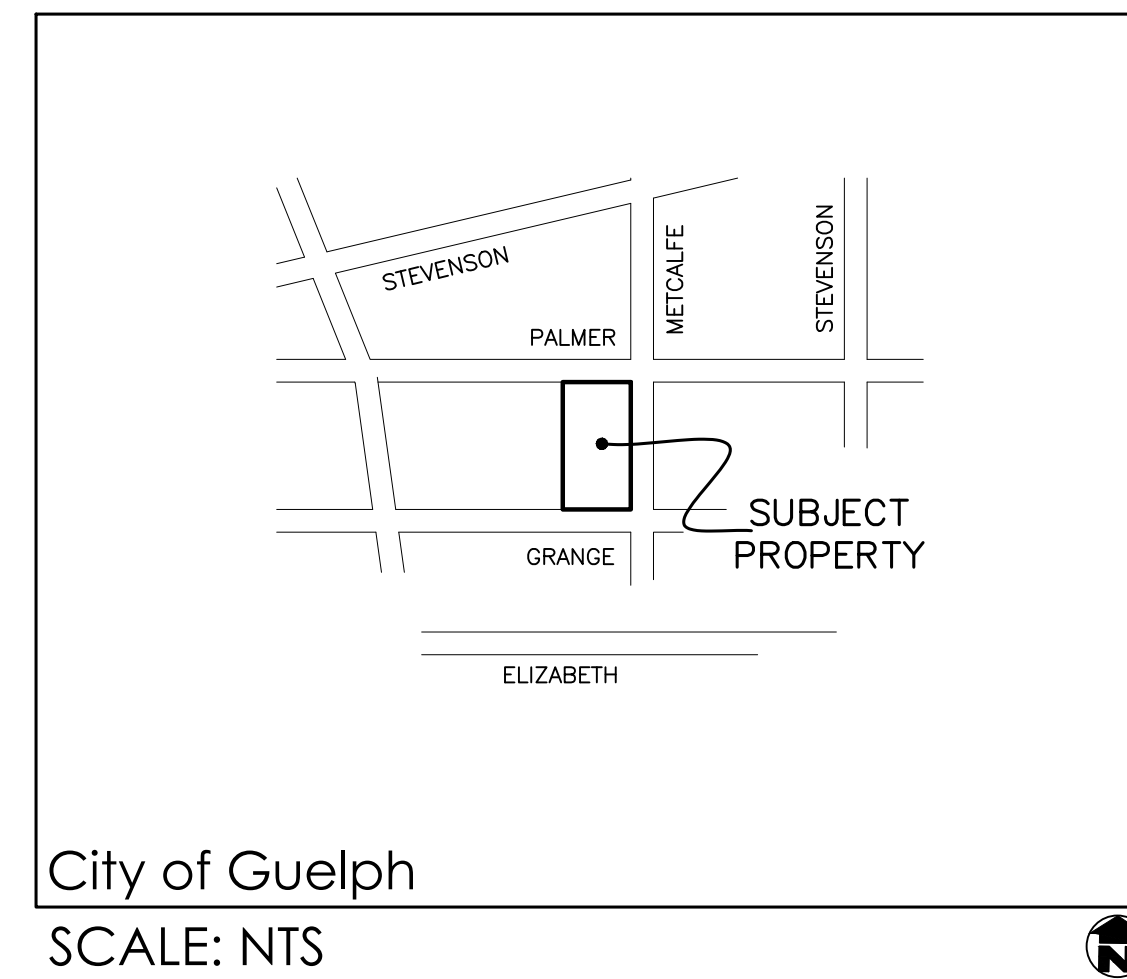

PARKS & RECREATION | PUBLIC SERVICES



REVISIONS			
No.	Date	Description	By
1.	Jun 7 21	Issued for tender	AWH
2.	Jul 29 21	Issued for construction	AWH

St. George's Park
City of Guelph
Contract #21-099

Key Plan




PROJECT NO.: 2020-77		DRAWN BY: DPV	
SCALE:		DESIGNED BY: AWH	
SHEET:		APPROVED BY: AWH	
L1		PLOT DATE: Jul 29 21	

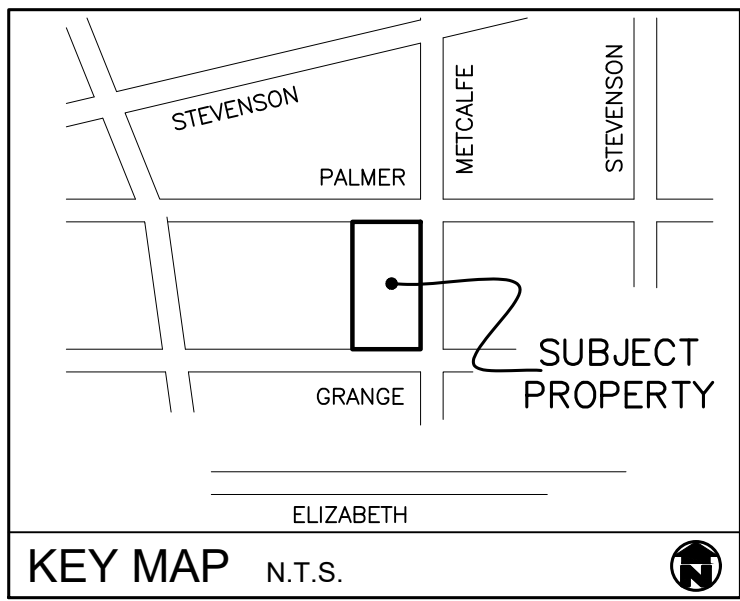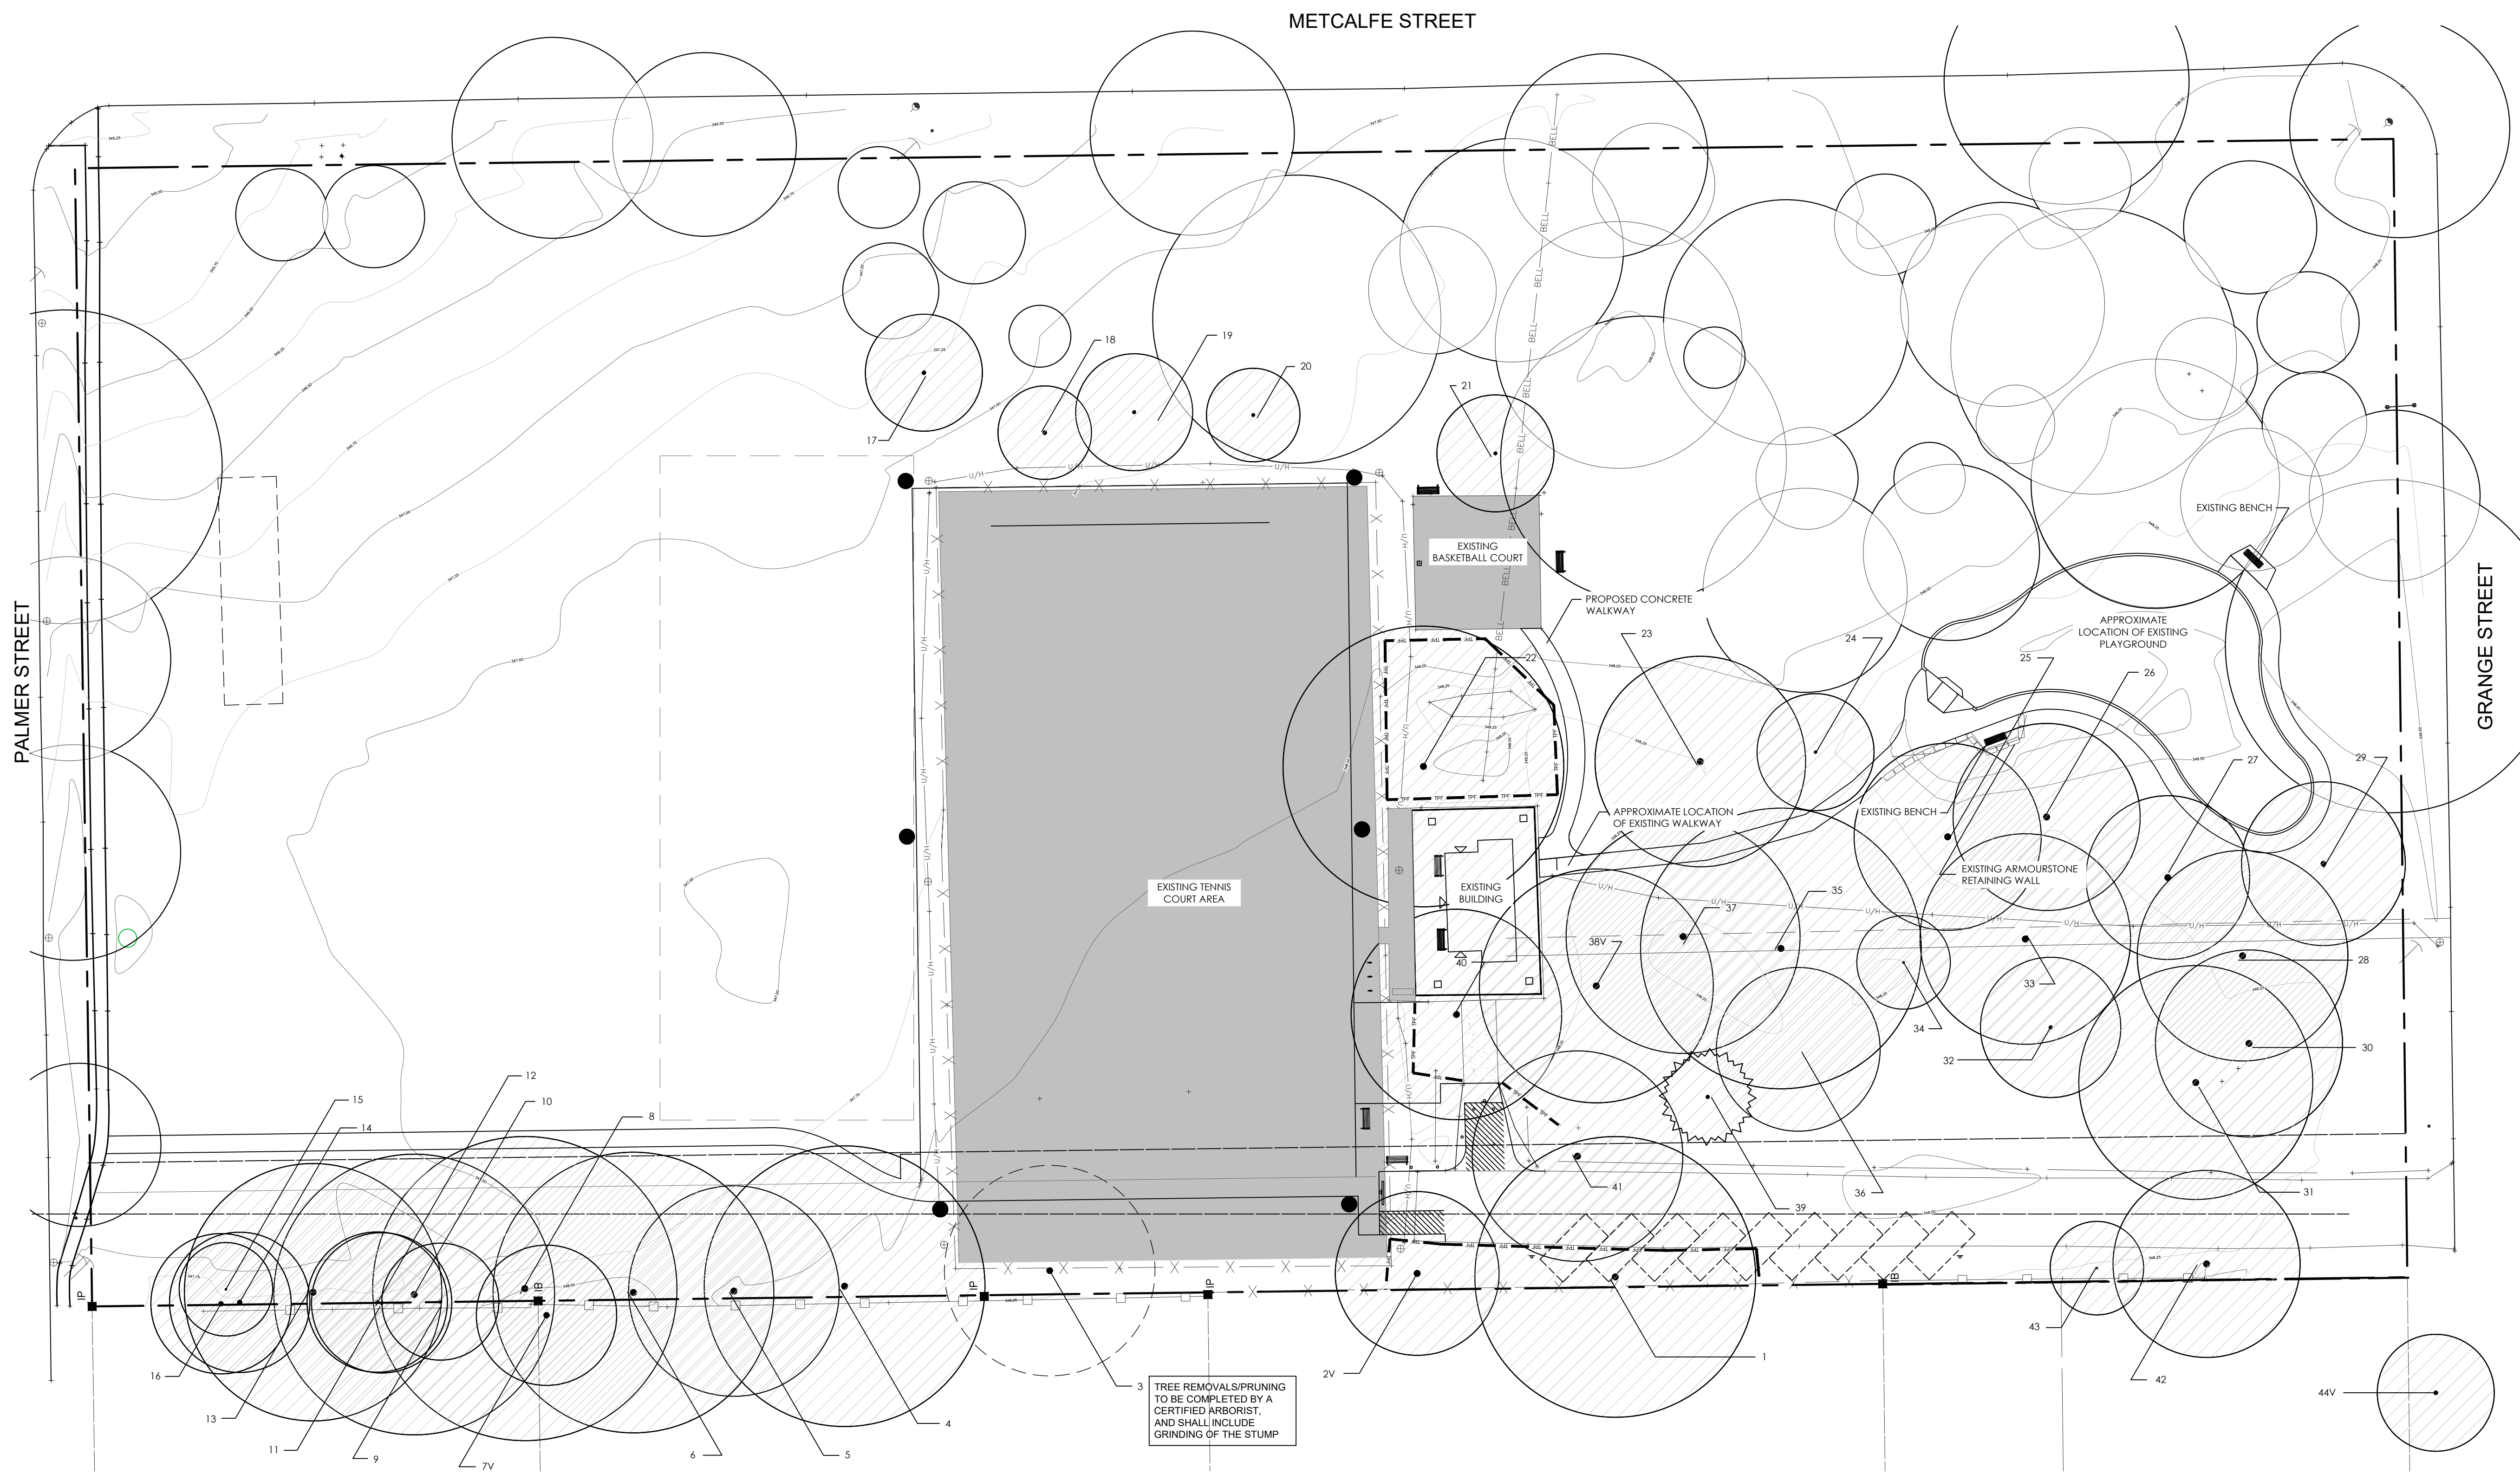

GENERAL NOTES


1. ALL WORKMANSHIP WILL BE TO THE STANDARDS OF LANDSCAPE ONTARIO.
2. EXISTING CONDITIONS SURVEY AS PER CITY OF GUELPH.

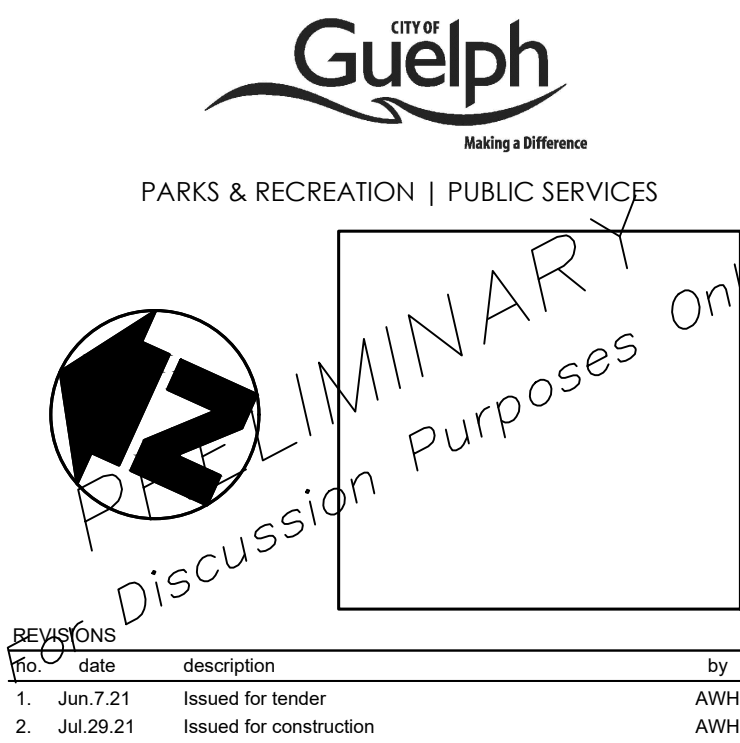

St. George's Park City of Guelph Contract #21-099 Tree Management Plan




PROJECT NO.: 2020-77
SCALE: 1:300
SHEET: L2
DRAWN BY: AWH
DESIGNED BY: AWH
APPROVED BY: AWH
PLOT DATE: Jul 29 21

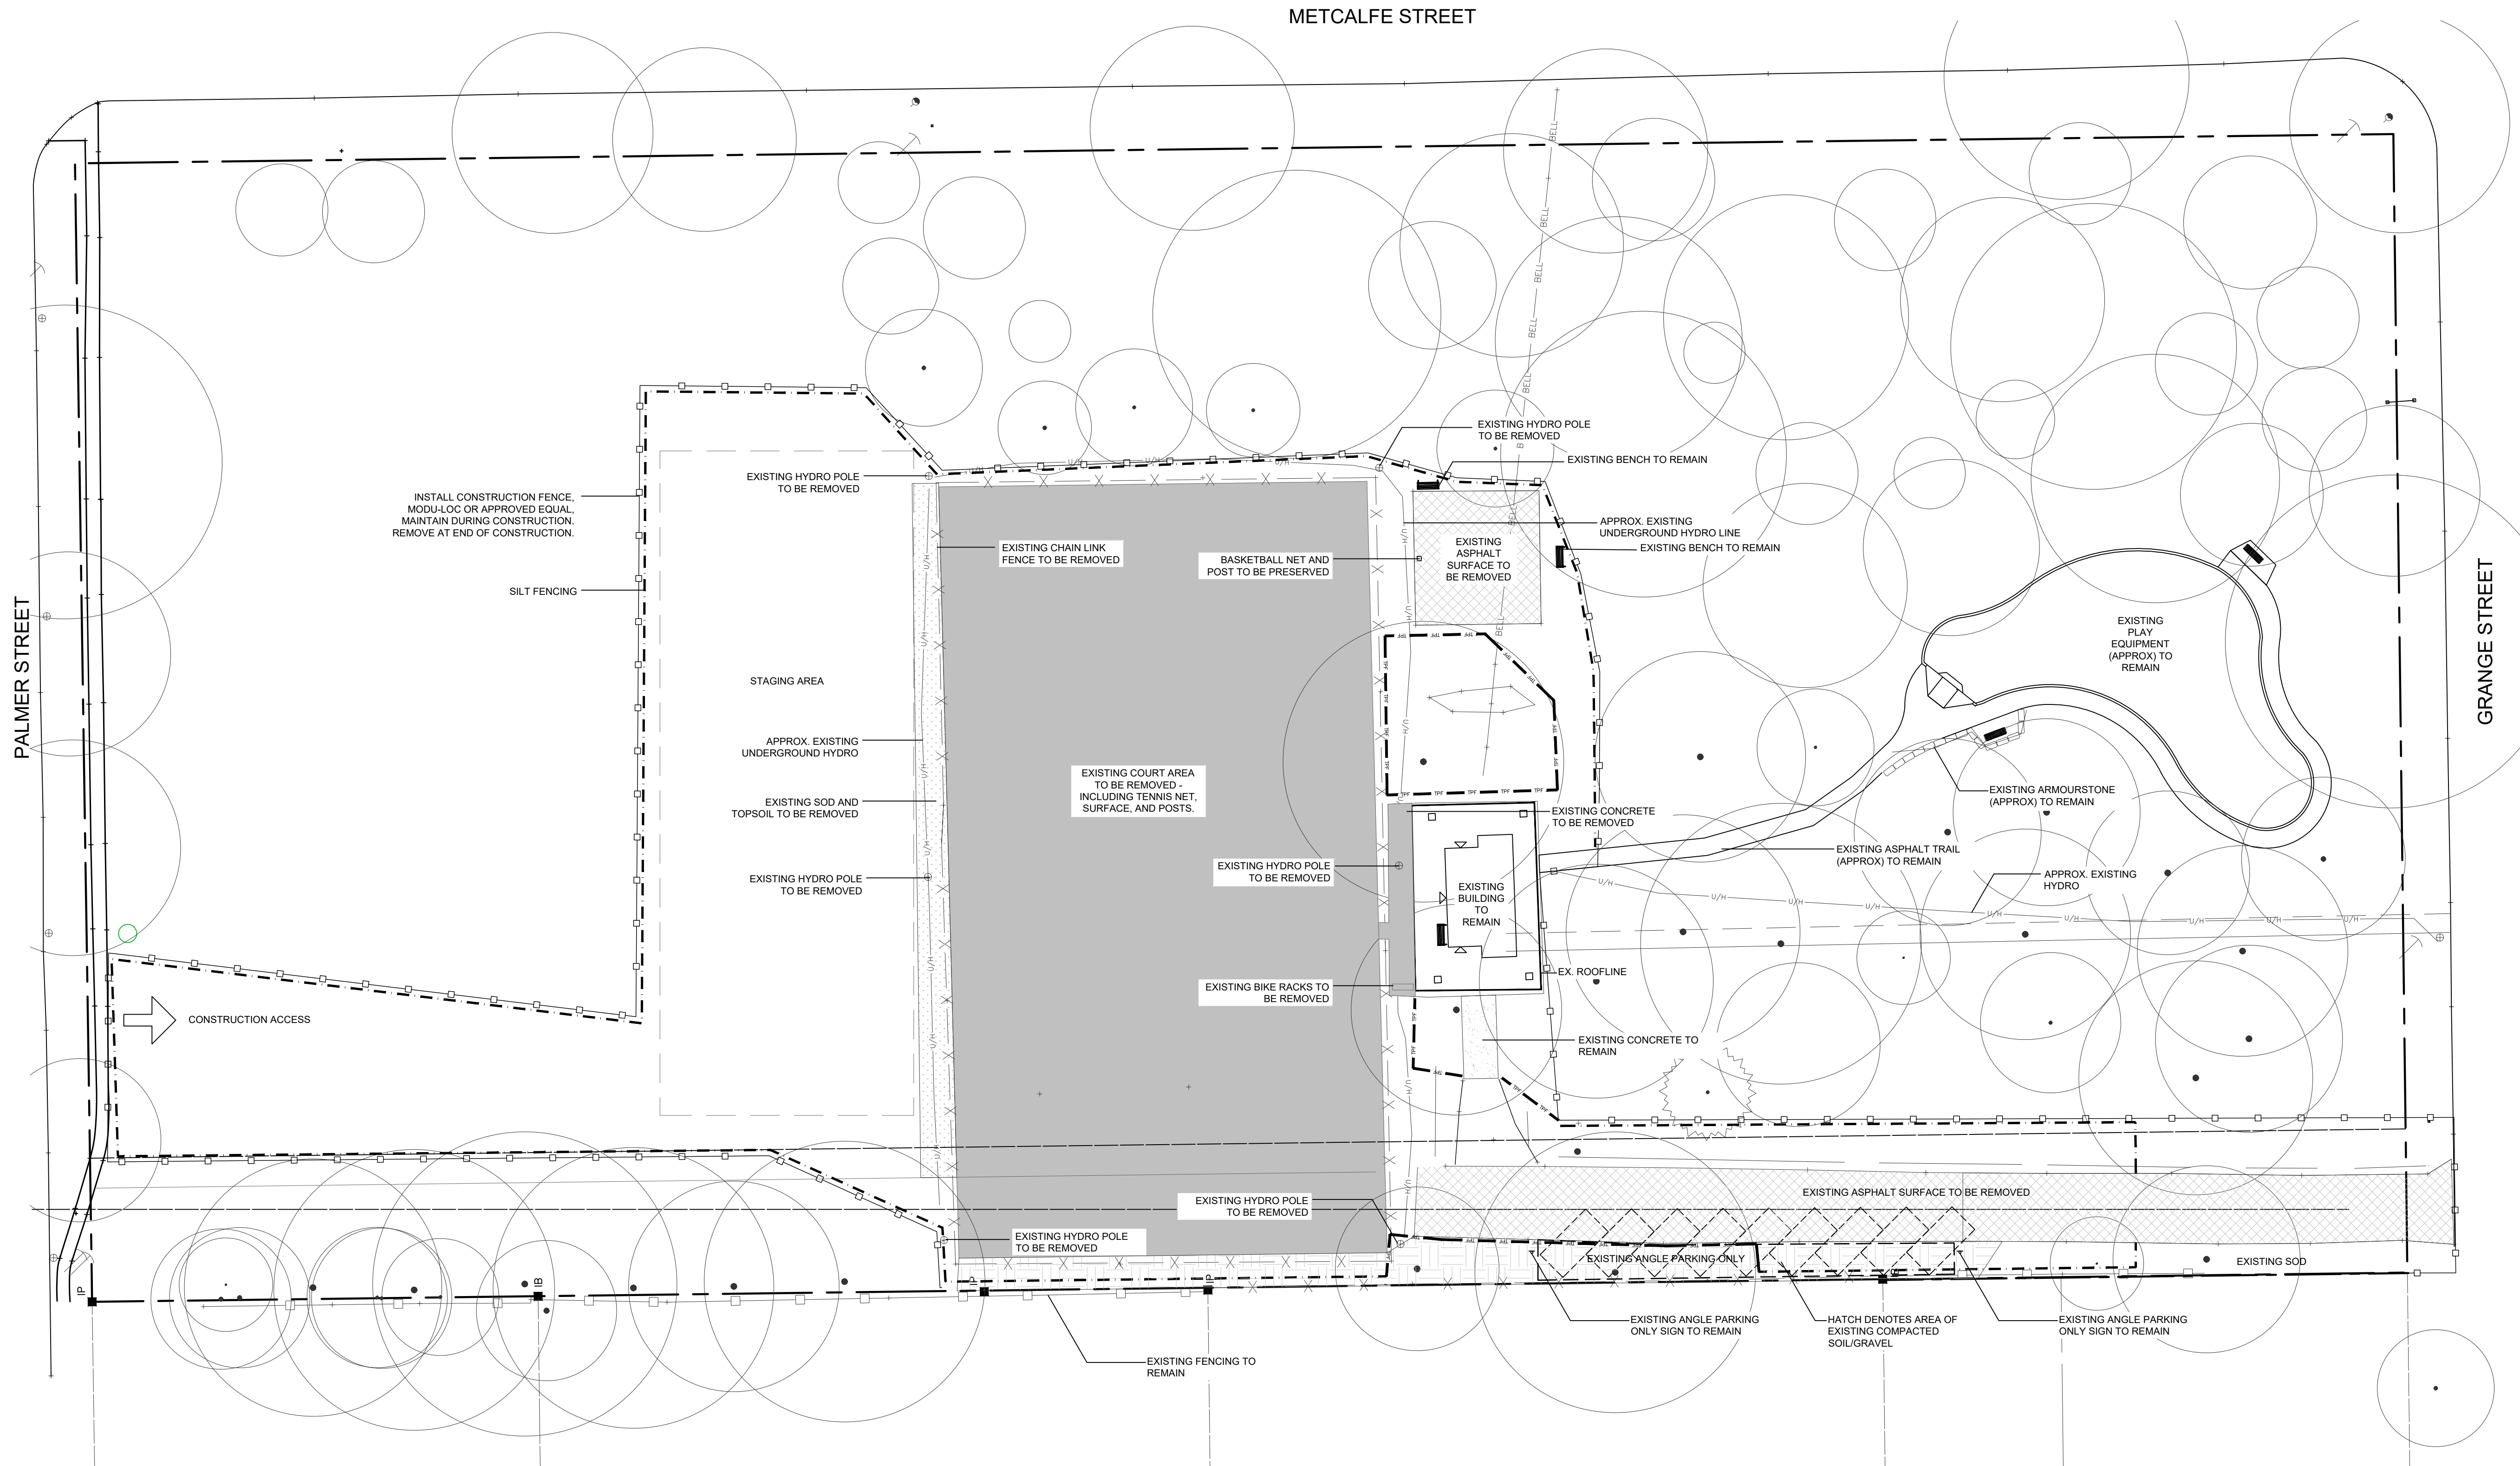

LEGEND

	TEMPORARY CONSTRUCTION FENCE MODU-LOC OR APPROVED EQUIVALENT (LIMIT OF WORK)
	TREE PROTECTION FENCE
	SILT FENCE

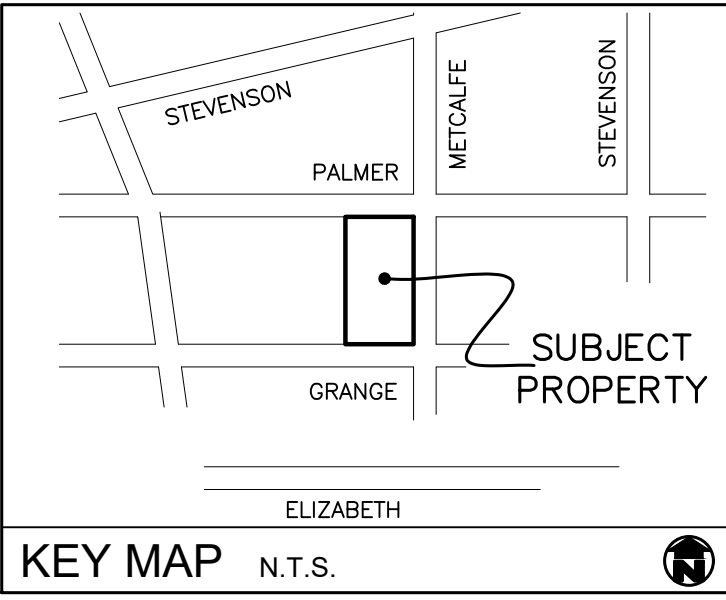

- ### GENERAL NOTES
1. ALL WORKMANSHIP WILL BE TO THE STANDARDS OF LANDSCAPE ONTARIO.
 2. ALL PLANT MATERIAL TO BE NO. 1 GRADE NURSERY GROWN IN ACCORDANCE WITH THE CANADIAN STANDARDS FOR NURSERY STOCK, 8TH EDITION, 2017, BY THE CANADIAN NURSERY TRADES ASSOCIATION.
 3. BACKFILL WILL CONSIST OF SOIL, NATIVE TO THE SITE OR GENERAL SOIL TYPE/CLASS NATIVE TO THE SITE. TOPSOIL TO BE TESTED FOR NUTRIENT VALUE, AND AMENDED FOR OPTIMAL GROWTH AS PER THE RECOMMENDATIONS OF THE SOIL TEST.
 4. CONTRACTOR SHALL MAINTAIN ALL LANDSCAPE AREAS UNTIL OWNER'S ACCEPTANCE OF PROJECT.
 5. CONTRACTOR TO LOCATE ALL UNDERGROUND UTILITIES.
 6. PLANTING MAY BE ADJUSTED TO SUIT LOCATIONS OF SITE UTILITY STRUCTURES/SERVICES.
 7. ALL MATERIALS MUST BE APPROVED BY LANDSCAPE ARCHITECT PRIOR TO INSTALLATION.
 8. SPREAD MULCH TO A MINIMUM OF 100mm COMPACTED DEPTH ON ALL TREE PITS AND PLANTING BEDS.
 9. CHECK AND VERIFY ALL DIMENSIONS AND QUANTITIES PRIOR TO COMMENCEMENT OF WORK. ANY DISCREPANCIES ARE TO BE REPORTED IN WRITING TO THE LANDSCAPE ARCHITECT. QUANTITIES NOTED WITHIN THE PLAN SUPERCEDE THOSE IN THE PLANT LIST. ANY SUBSTITUTIONS SHALL BE APPROVED BY THE LANDSCAPE ARCHITECT.
 10. SOD AS MARKED WITH NURSERY SOD ON A MINIMUM OF 100mm OF CLEAN TOPSOIL. FINE GRADE AND SOD ALL BOULEVARD AREAS TO MUNICIPAL SPECIFICATIONS AND REPAIR DAMAGE TO ADJACENT PROPERTIES, AS REQUIRED.
 11. FINAL INSPECTION AND ACCEPTANCE OF PLANTING WORK SHALL COINCIDE WITH THE FINAL INSPECTION AND ACCEPTANCE OF ALL WORK INCLUDED IN THE CONTRACT.
 12. ALL SEEDED SLOPES 3:1 AND GREATER TO RECEIVE EROSION CONTROL MATTING. PIN SOD ON ALL SLOPES OF 3:1 OR GREATER.
 13. SUBMIT A WRITTEN GUARANTEE TO THE EFFECT THAT ALL PLANTS ACCEPTED DURING THE PERIOD OF JANUARY 1st TO JULY 15th SHALL BE GUARANTEED UNTIL JULY 15th THE FOLLOWING YEAR. PLANTS ACCEPTED DURING THE PERIOD OF JULY 15th TO DECEMBER 31st SHALL BE GUARANTEED FOR ONE YEAR FROM THE DATE OF ACCEPTANCE. THE GUARANTEE PERIODS LISTED ABOVE SHALL APPLY TO ALL 'NURSERY GROWN' PLANTS.
 14. AT THE TIME OF FINAL INSPECTION ALL PLANTS SHALL BE IN A HEALTHY, VIGOROUS GROWING CONDITION, PLANTED IN FULL ACCORDANCE WITH DRAWINGS AND CONDITIONS.
 15. EXISTING CONDITIONS SURVEY AS PER CITY OF GUELPH/VAN HARTEN SURVEYING.
 16. SITE LIGHTING BY MIGHTON ENGINEERING.

PARKS & RECREATION | PUBLIC SERVICES

PRELIMINARY
Discussion Purposes only


REVISION	DATE	DESCRIPTION	BY
1	Jun 7 21	Issued for tender	AWH
2	Jul 29 21	Issued for construction	AWH

St. George's Park
City of Guelph
Contract #21-099


Construction Management
and Removals Plan




PROJECT NO.: 2020-77	DRAWN BY: DPV
SCALE: 1:300	DESIGNED BY: AWH
SHEET: L3	APPROVED BY: AWH
	PLOT DATE: Jul 29 21

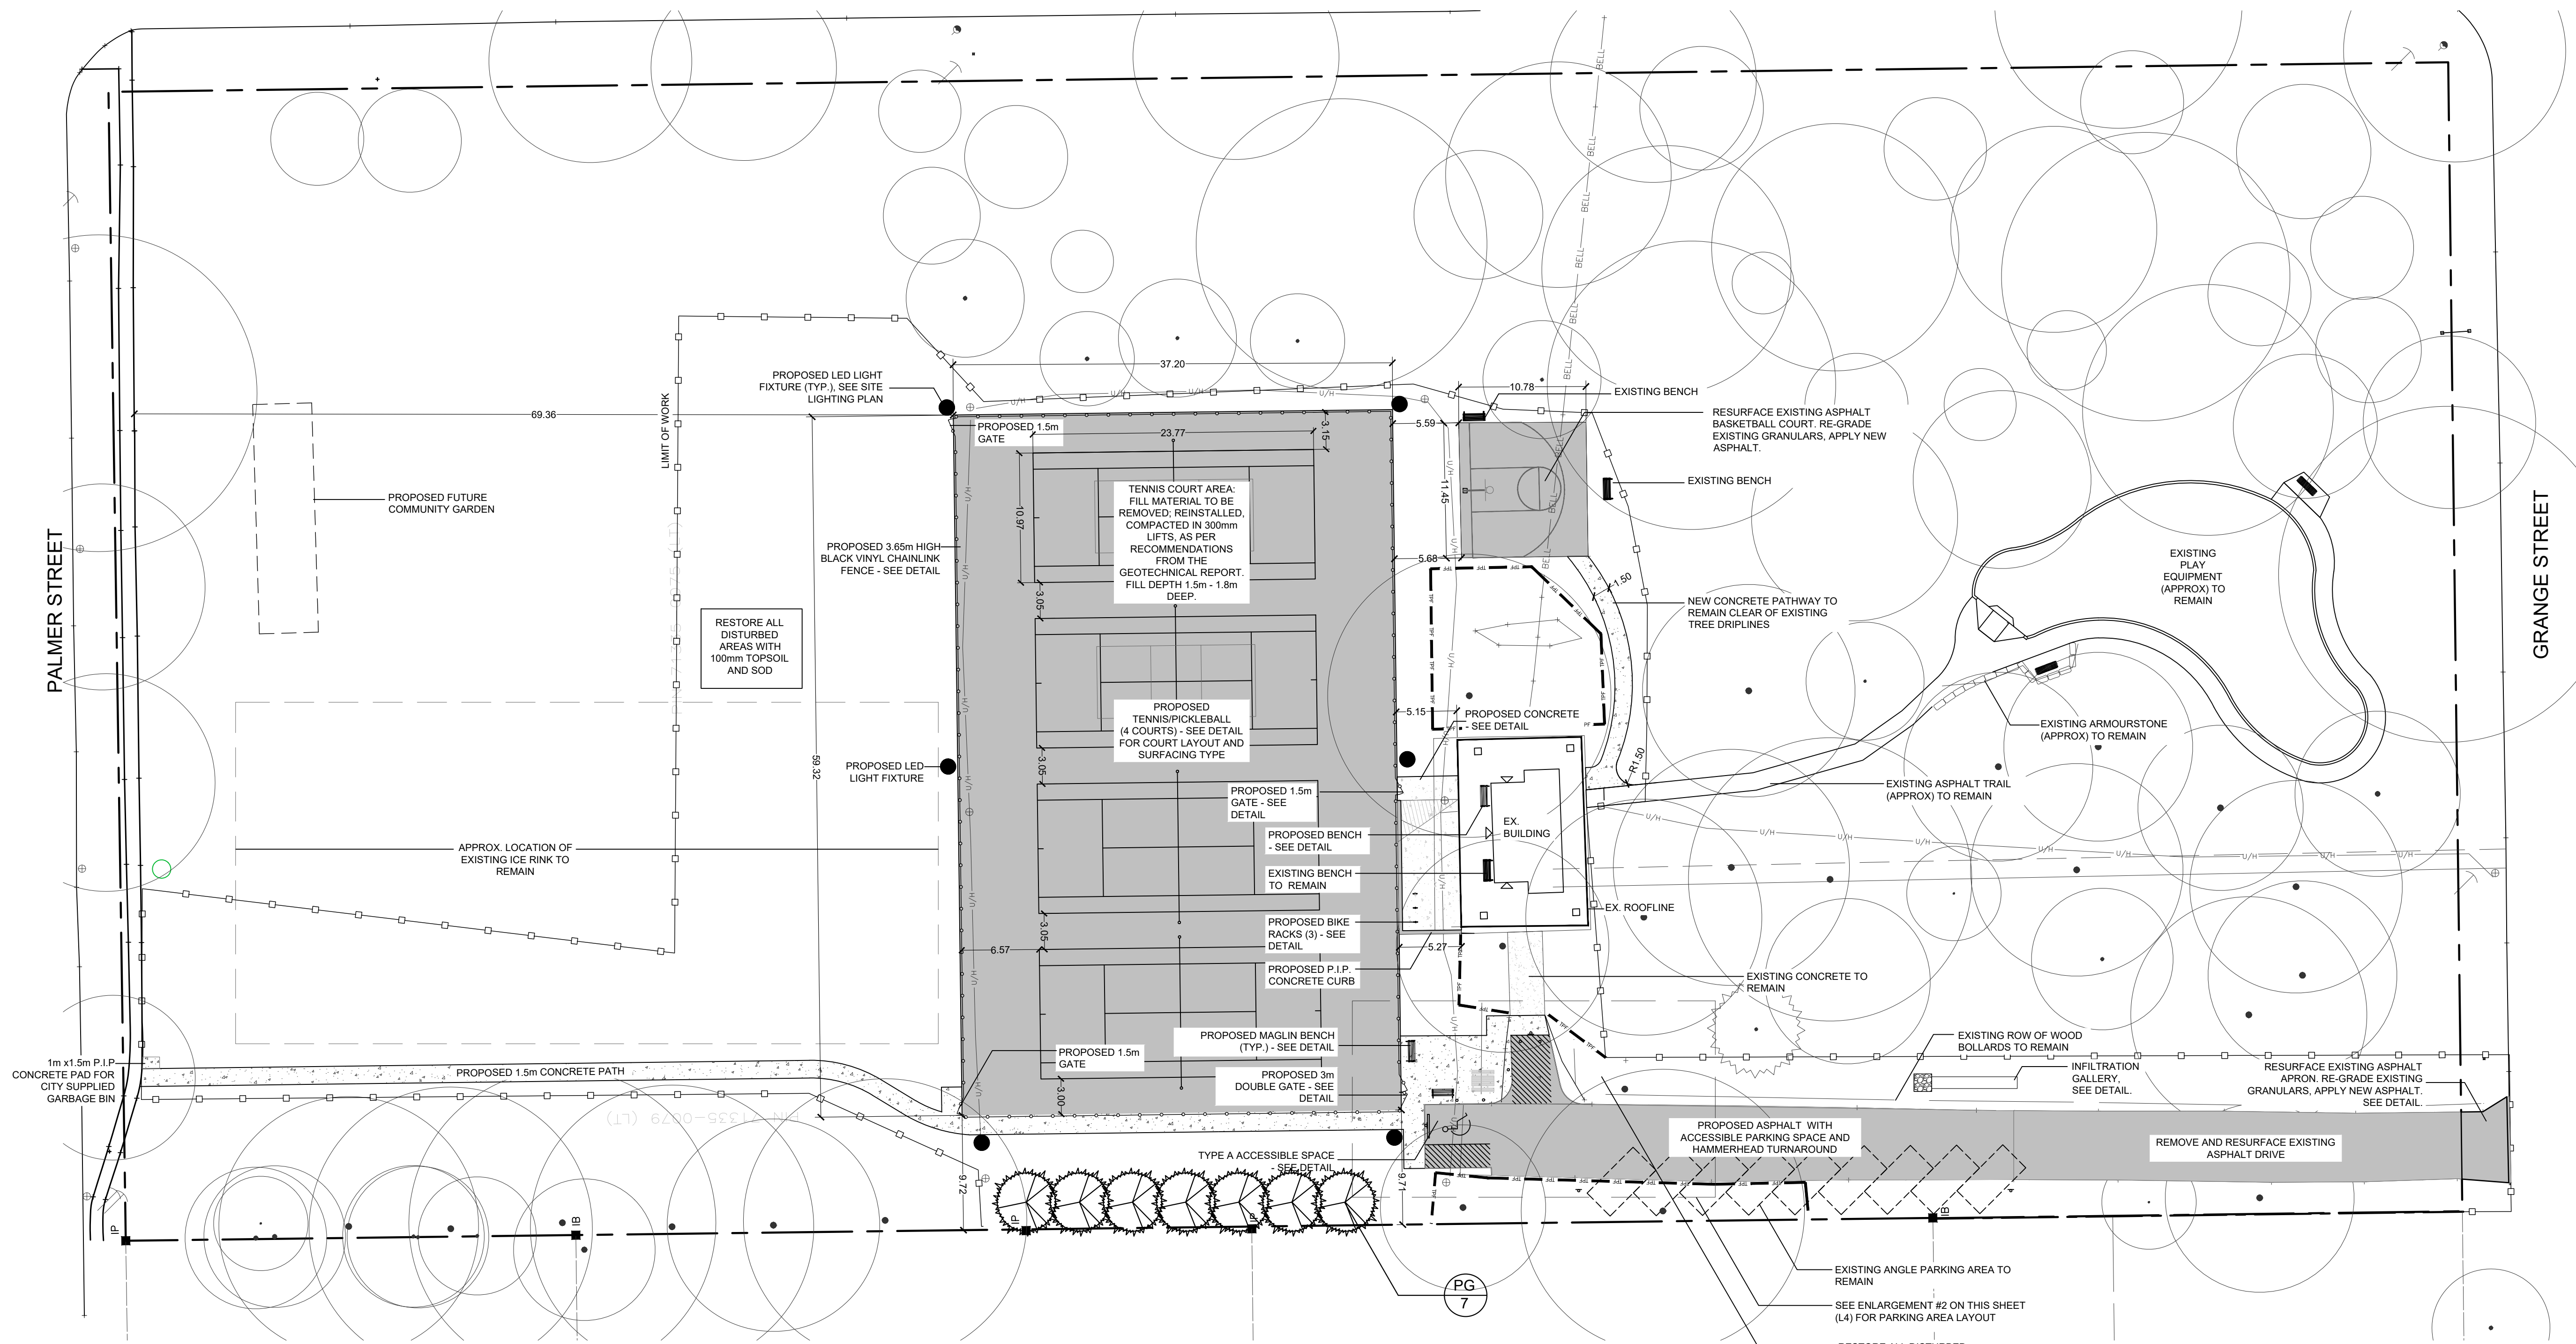


PLANT MATERIAL LIST					
KEY	QUANT.	BOTANICAL NAME	COMMON NAME	SIZE	COND.
PG	7	Picea glauca	White Spruce	250cm HT.	W.B.

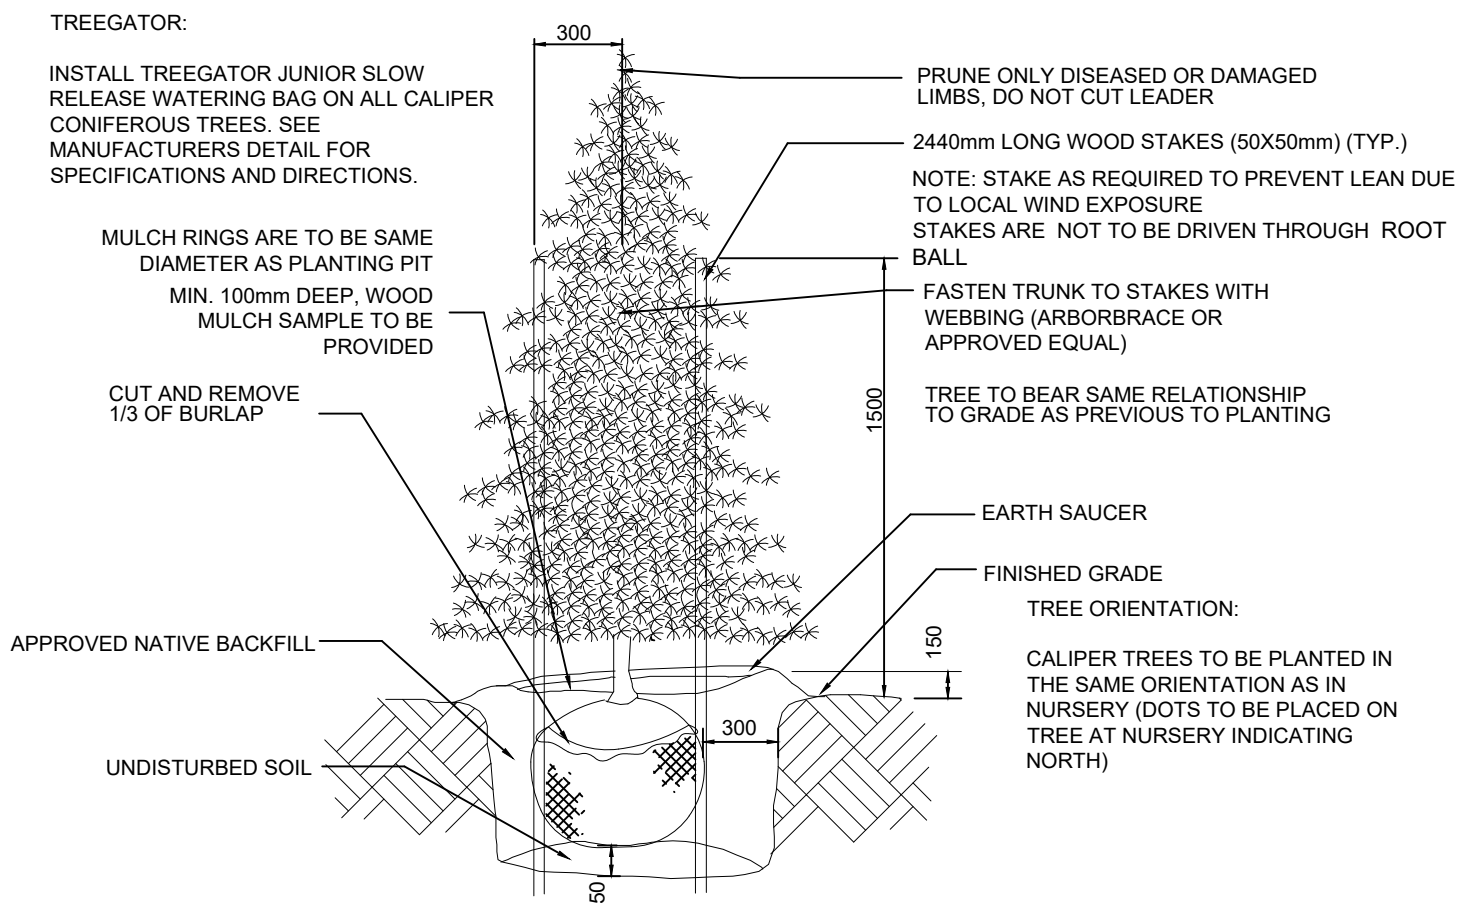

1 CONIFEROUS TREE PLANTING DETAIL
NTS

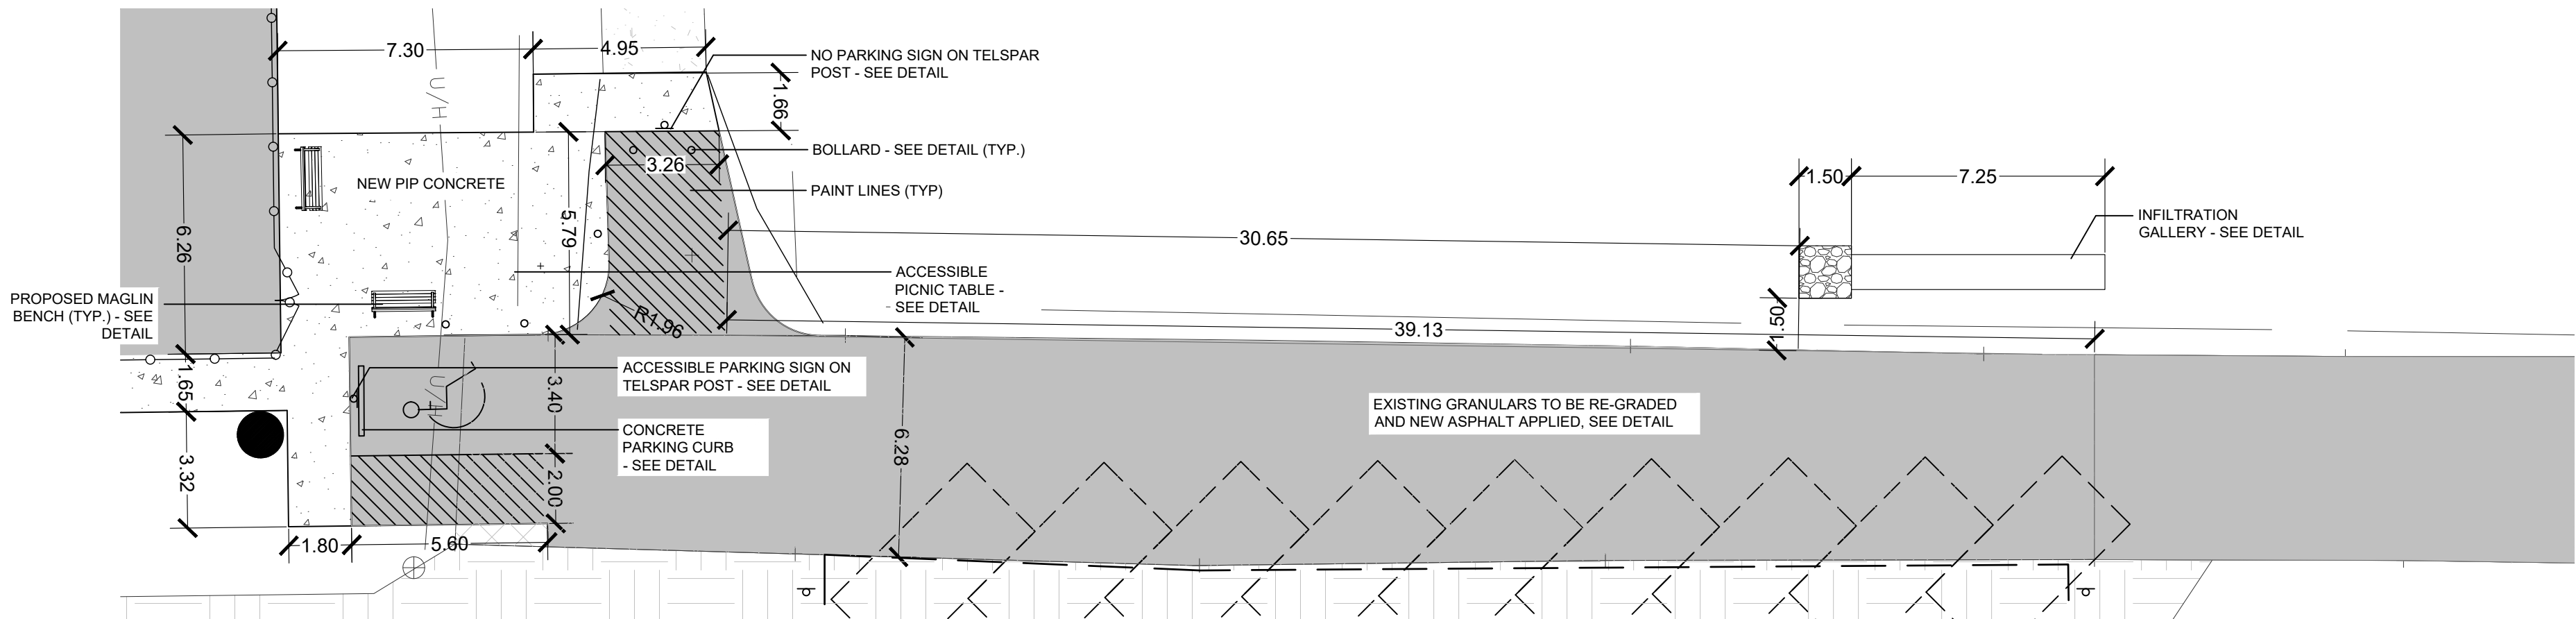

2 PARKING LAYOUT ENLARGEMENT
1:150

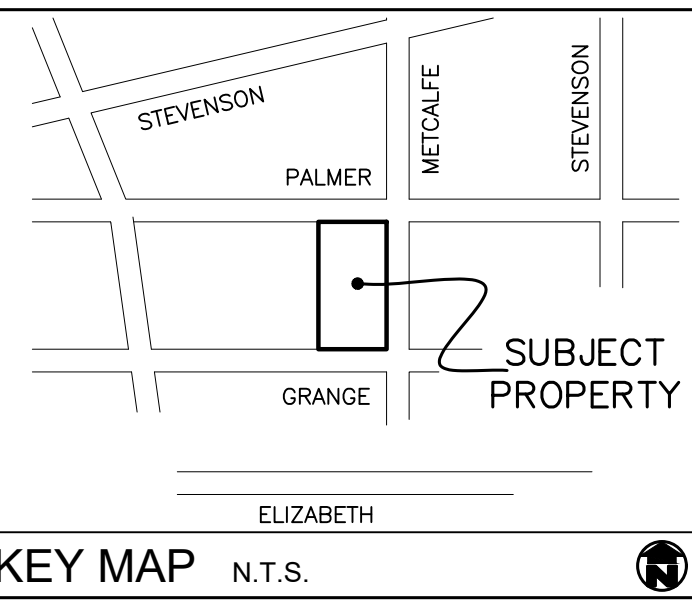

GENERAL NOTES

1. ALL WORKMANSHIP WILL BE TO THE STANDARDS OF LANDSCAPE ONTARIO.
2. ALL PLANT MATERIAL TO BE NO. 1 GRADE NURSERY GROWN IN ACCORDANCE WITH THE CANADIAN STANDARDS FOR NURSERY STOCK, 8TH EDITION, 2017, BY THE CANADIAN NURSERY TRADES ASSOCIATION.
3. BACKFILL WILL CONSIST OF SOIL NATIVE TO THE SITE OR GENERAL SOIL TYPE/CLASS NATIVE TO THE SITE. TOPSOIL TO BE TESTED FOR NUTRIENT VALUE, AND AMENDED FOR OPTIMAL GROWTH AS PER THE RECOMMENDATIONS OF THE SOIL TEST.
4. CONTRACTOR SHALL MAINTAIN ALL LANDSCAPE AREAS UNTIL OWNER'S ACCEPTANCE OF PROJECT.
5. CONTRACTOR TO LOCATE ALL UNDERGROUND UTILITIES.
6. PLANTING MAY BE ADJUSTED TO SUIT LOCATIONS OF SITE UTILITY STRUCTURES/SERVICES.
7. ALL MATERIALS MUST BE APPROVED BY LANDSCAPE ARCHITECT PRIOR TO INSTALLATION.
8. SPREAD MULCH TO A MINIMUM OF 100mm COMPACTED DEPTH ON ALL TREE PITS AND PLANTING BEDS.
9. CHECK AND VERIFY ALL DIMENSIONS AND QUANTITIES PRIOR TO COMMENCEMENT OF WORK. ANY DISCREPANCIES ARE TO BE REPORTED IN WRITING TO THE LANDSCAPE ARCHITECT. QUANTITIES NOTED WITHIN THE PLAN SUPERCEDE THOSE IN THE PLANT LIST. ANY SUBSTITUTIONS SHALL BE APPROVED BY THE LANDSCAPE ARCHITECT.
10. SOD AS MARKED WITH NURSERY SOD ON A MINIMUM OF 100mm OF CLEAN TOPSOIL. FINE GRADE AND SOD ALL BOULEVARD AREAS TO MUNICIPAL SPECIFICATIONS AND REPAIR DAMAGE TO ADJACENT PROPERTIES, AS REQUIRED.
11. FINAL INSPECTION AND ACCEPTANCE OF PLANTING WORK SHALL COINCIDE WITH THE FINAL INSPECTION AND ACCEPTANCE OF ALL WORK INCLUDED IN THE CONTRACT.
12. ALL SEEDED SLOPES 3:1 AND GREATER TO RECEIVE EROSION CONTROL MATTING. PIN SOD ON ALL SLOPES OF 3:1 OR GREATER.
13. SUBMIT A WRITTEN GUARANTEE TO THE EFFECT THAT ALL PLANTS ACCEPTED DURING THE PERIOD OF JANUARY 1st TO JULY 15th SHALL BE GUARANTEED UNTIL JULY 15th THE FOLLOWING YEAR. PLANTS ACCEPTED DURING THE PERIOD OF JULY 15th TO DECEMBER 31st SHALL BE GUARANTEED FOR ONE YEAR FROM THE DATE OF ACCEPTANCE. THE GUARANTEE PERIODS LISTED ABOVE SHALL APPLY TO ALL 'NURSERY GROWN' PLANTS.
14. AT THE TIME OF FINAL INSPECTION ALL PLANTS SHALL BE IN A HEALTHY, VIGOROUS GROWING CONDITION, PLANTED IN FULL ACCORDANCE WITH DRAWINGS AND CONDITIONS.
15. EXISTING CONDITIONS SURVEY AS PER CITY OF GUELPH/VAN HARTEN SURVEYING.
16. SITE LIGHTING BY OTHERS.

CITY OF Guelph
Making a Difference
PARKS & RECREATION | PUBLIC SERVICES

PROVISIONAL
Discussion Purposes only


REVISIONS

NO.	DATE	DESCRIPTION	BY
1	Jun 7 21	Issued for tender	AWH
2	Jul 29 21	Issued for construction	AWH


St. George's Park
City of Guelph
Contract #21-099
Layout/Planting Plan



PROJECT NO.: 2020-77
SCALE: 1:300
SHEET: L4
DRAWN BY: DPV
DESIGNED BY: AWH
APPROVED BY: AWH
PLOT DATE: Jul 29 21

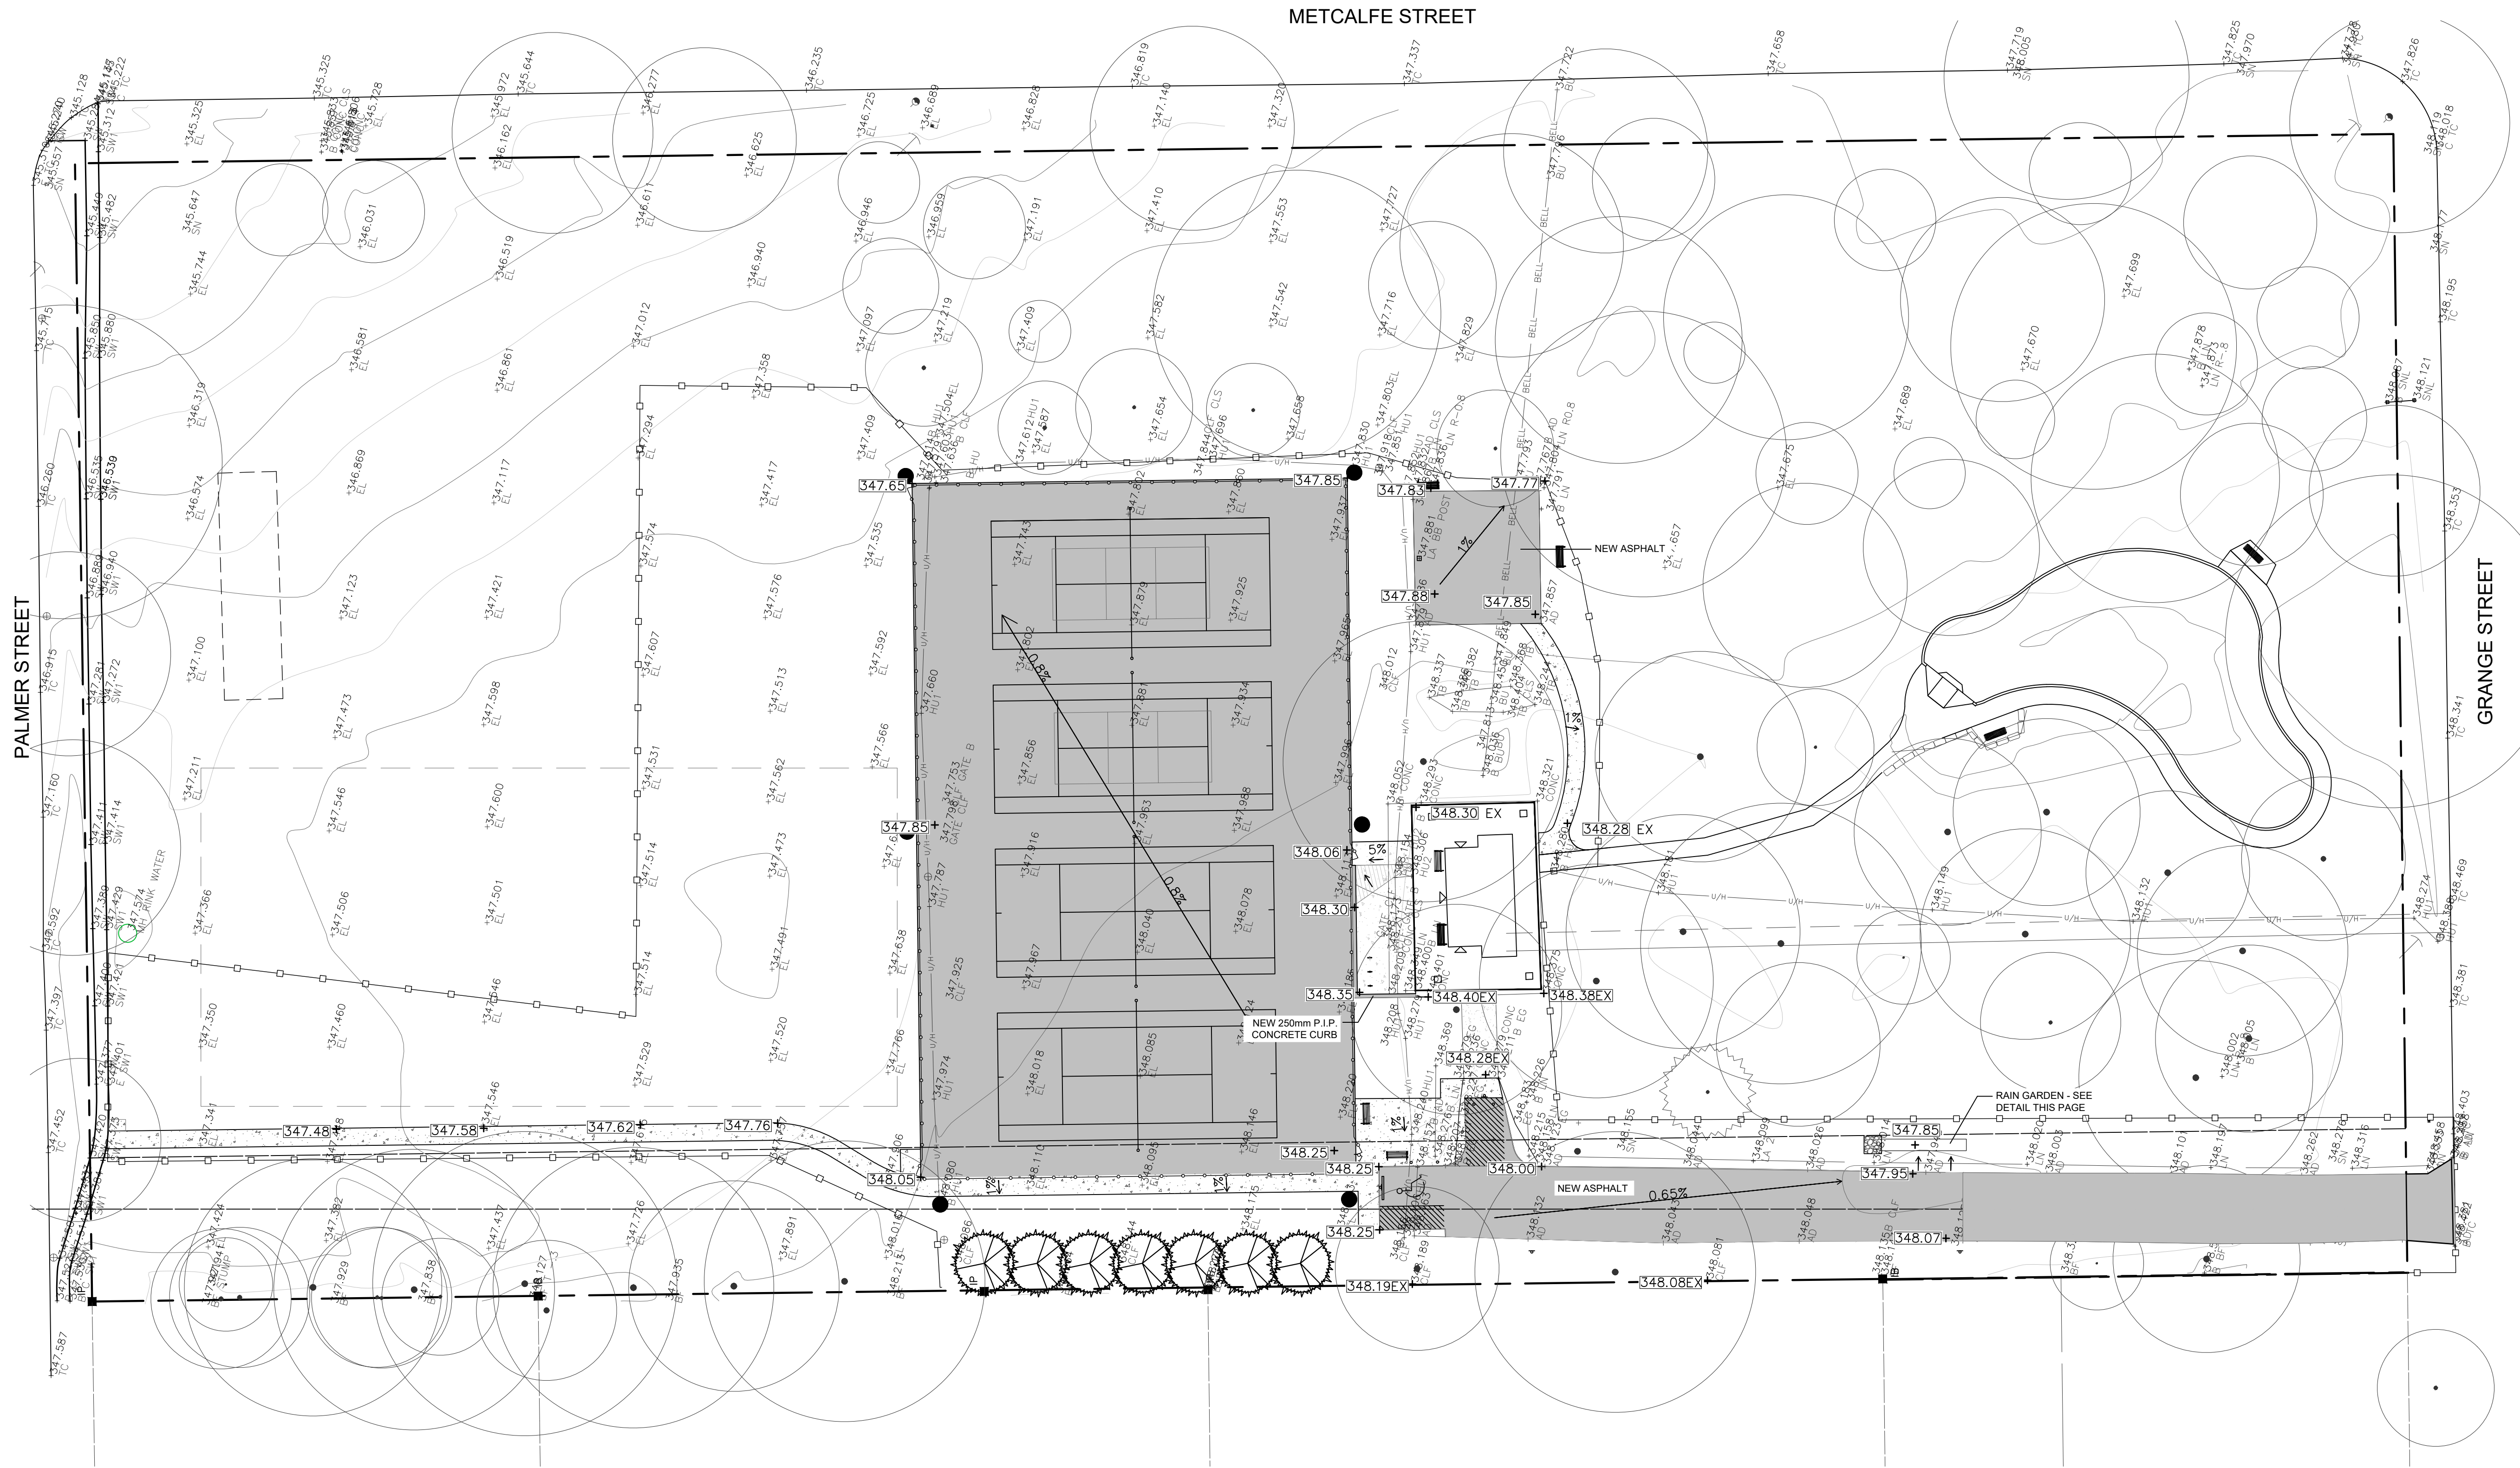

LEGEND

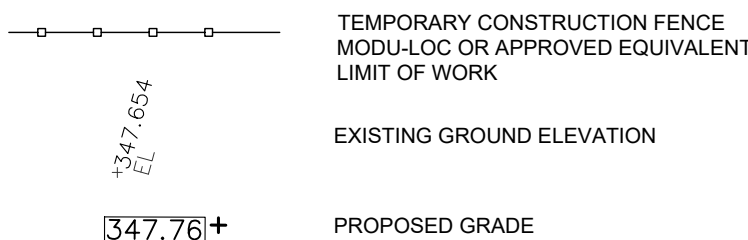

BENCHMARK No. 106

BRASS TABLET LOCATED ON BRICK HOUSE BETWEEN STUART AND QUEEN STREET ON PALMER STREET ON SOUTHWEST CORNER OF DWELLING No. 84, 2.5 FEET ABOVE GROUND LEVEL AND 6 INCHES BACK FROM CORNER HAVING AN ELEVATION OF 346.720 METRES.

SITE BENCHMARK

NAIL AND WASHERS IN LIGHT STANDARD, PALMER SIDE OF TENNIS COURTS AT CENTRE, HAVING AN ELEVATION OF 348.18 METRE

NAIL AND WASHERS IN LIGHT STANDARD, GRANGE ST SIDE OF TENNIS COURTS AT WEST END, HAVING AN ELEVATION OF 348.48 METRE


SEED MIX

8245 -SWM POND MIX WET/DRY MIX


- 3% BLACK EYED SUSAN (RUDBECKIA HIRTA)
- 20% CANADIAN WILD RYE (ELYMUS CANADENSIS)
- 17% FOX SEDGE (CAREX VULPINOIDEA)
- 15% INDIAN GRASS (SORGHASTRUM NUTANS)
- 3% NEW ENGLAND ASTER (ASTER NOVAE-ANGLIAE)
- 1% SPOTTED JOE PYE WEEED (EUPATORIUM MACULATUM)
- 20% SWITCHGRASS (PANICUM VIRGATUM)
- 20% VIRGINIA WILD RYE (ELYMUS VIRGINICUS)
- 1% WILD BERGAMOT (MONARDA FISTULOSA)

TO BE APPLIED AT A RATE OF 25kg/ha


PLAN

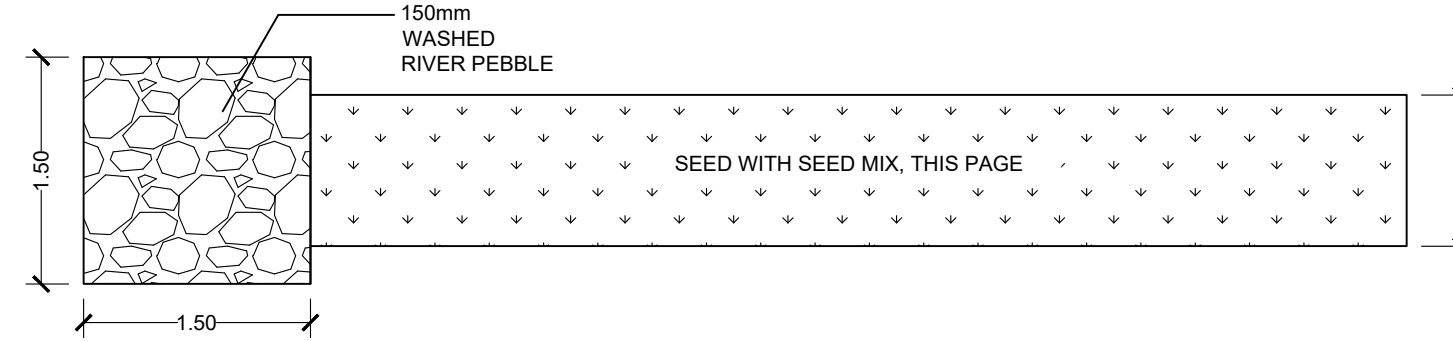

PROFILE

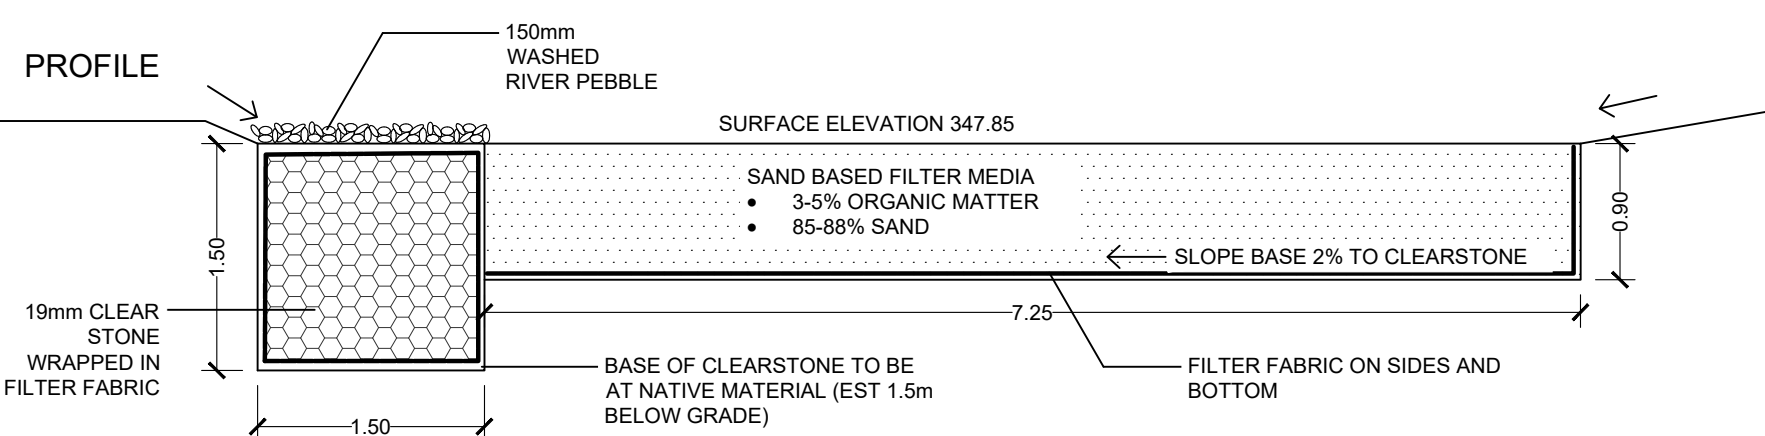

RAIN GARDEN DETAIL

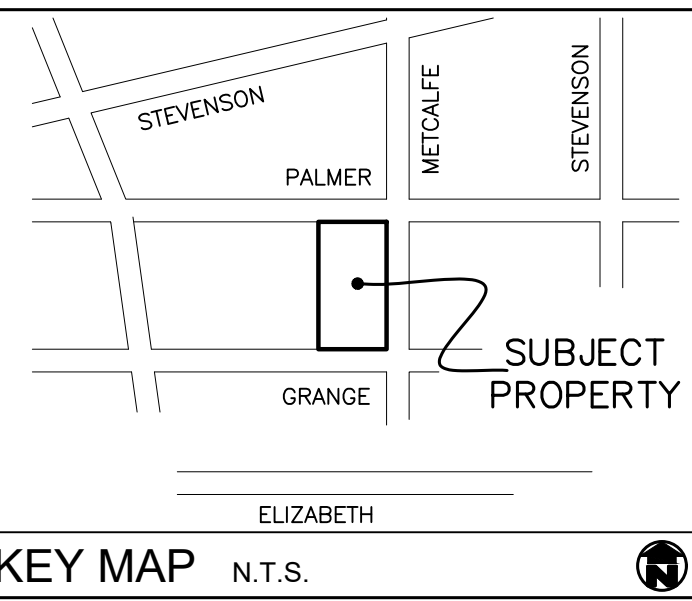

GENERAL NOTES

1. ALL WORKMANSHIP WILL BE TO THE STANDARDS OF LANDSCAPE ONTARIO.
2. ALL PLANT MATERIAL TO BE NO.1 GRADE NURSERY GROWN IN ACCORDANCE WITH THE CANADIAN STANDARDS FOR NURSERY STOCK, 9TH EDITION, 2017, BY THE CANADIAN NURSERY TRADES ASSOCIATION.
3. BACKFILL WILL CONSIST OF SOIL NATIVE TO THE SITE OR GENERAL SOIL TYPE/CLASS NATIVE TO THE SITE. TOPSOIL TO BE TESTED FOR NUTRIENT VALUE, AND AMENDED FOR OPTIMAL GROWTH AS PER THE RECOMMENDATIONS OF THE SOIL TEST.
4. CONTRACTOR SHALL MAINTAIN ALL LANDSCAPE AREAS UNTIL OWNERS ACCEPTANCE OF PROJECT.
5. CONTRACTOR TO LOCATE ALL UNDERGROUND UTILITIES.
6. PLANTING MAY BE ADJUSTED TO SUIT LOCATIONS OF SITE UTILITY STRUCTURES/SERVICES.
7. ALL MATERIALS MUST BE APPROVED BY LANDSCAPE ARCHITECT PRIOR TO INSTALLATION.
8. SPREAD MULCH TO A MINIMUM OF 100mm COMPACTED DEPTH ON ALL TREE PITS AND PLANTING BEDS.
9. CHECK AND VERIFY ALL DIMENSIONS AND QUANTITIES PRIOR TO COMMENCEMENT OF WORK. ANY DISCREPANCIES ARE TO BE REPORTED IN WRITING TO THE LANDSCAPE ARCHITECT. QUANTITIES NOTED WITHIN THE PLAN SUPERCEDE THOSE IN THE PLANT LIST. ANY SUBSTITUTIONS SHALL BE APPROVED BY THE LANDSCAPE ARCHITECT.
10. SOD AS MARKED WITH NURSERY SOD ON A MINIMUM OF 100mm OF CLEAN TOPSOIL. FINE GRADE AND SOD ALL BOULEVARD AREAS TO MUNICIPAL SPECIFICATIONS AND REPAIR DAMAGE TO ADJACENT PROPERTIES, AS REQUIRED.
11. FINAL INSPECTION AND ACCEPTANCE OF PLANTING WORK SHALL COINCIDE WITH THE FINAL INSPECTION AND ACCEPTANCE OF ALL WORK INCLUDED IN THE CONTRACT.
12. ALL SEEDED SLOPES 3:1 AND GREATER TO RECEIVE EROSION CONTROL MATTING. PIN SOD ON ALL SLOPES OF 3:1 OR GREATER.
13. SUBMIT A WRITTEN GUARANTEE TO THE EFFECT THAT ALL PLANTS ACCEPTED DURING THE PERIOD OF JANUARY 1st TO JULY 15th SHALL BE GUARANTEED UNTIL JULY 15th THE FOLLOWING YEAR. PLANTS ACCEPTED DURING THE PERIOD OF JULY 15th TO DECEMBER 31st SHALL BE GUARANTEED FOR ONE YEAR FROM THE DATE OF ACCEPTANCE. THE GUARANTEE PERIODS LISTED ABOVE SHALL APPLY TO ALL "NURSERY GROWN" PLANTS.
14. AT THE TIME OF FINAL INSPECTION ALL PLANTS SHALL BE IN A HEALTHY, VIGOROUS GROWING CONDITION, PLANTED IN FULL ACCORDANCE WITH DRAWINGS AND CONDITIONS.
15. EXISTING CONDITIONS SURVEY AS PER CITY OF GUELPH/VAN HARTEN SURVEYING.
16. SITE LIGHTING BY OTHERS.



REV	DATE	DESCRIPTION	BY
1.	Jun 7 21	Issued for tender	AWH
2.	Jul 29 21	Issued for construction	AWH

St. George's Park
City of Guelph
Contract #21-099

Grading Plan



PROJECT NO.: 2020-77	DRAWN BY: DPV
SCALE: 1:300	DESIGNED BY: AWH
SHEET:	APPROVED BY: AWH
L5	PLOT DATE: Jul 29 21